

**STREET TREE CHART**

(FOR STREET TREES ON CITY LAND OR WITHIN 10' OF STREET/SCAPE PROPERTY LINES)

STREET/SCAPE ROAD AREA	TOTAL STREET FRONTAGE (L)	REQUIRED STREET TREES (FRONTAGE/25)	STREET TREES EXISTING	STREET TREES PROPOSED	TREES SUBJECT TO FEE PAYMENT (STREET TREES REQUIRED - STREET TREES EXISTING - STREET TREES PROPOSED - CONSENS)	FEE IN LIEU REQUIRED (\$2500 PER TREE SUBJECT TO FEE PAYMENT)
GLENBROOK ROAD	50'	2.0	0	3	(2.0 - 0.3 = 1.0)	\$0
PARKING AVENUE	100'	4.0	0	5	(4.0 - 0.5 = 1.0)	\$0
<b>SUBTOTAL:</b>						\$0

**PLANT LIST - POLLINATOR PATHWAY GARDEN**

QTY	BOTANICAL NAME	COMMON NAME	SIZE
10	ASCLEPIAS TUBEROSA	SWAMP MILKWEEED	1.0T.
10	ASCLEPIAS TUBEROSA	BUTTERFLY WEED	1.0T.
10	ASCLEPIAS TUBEROSA	MONARDELLA	1.0T.
10	ASCLEPIAS TUBEROSA	MOUNTAIN MINT	1.0T.
10	ASCLEPIAS TUBEROSA	BLACK ECHINACEA	1.0T.
10	ASCLEPIAS TUBEROSA	RUDEBECKIA HIRTA	1.0T.

NOTE: LANDSCAPE ARCHITECT SHALL LOCATE PLANTING LOCATIONS IN THE FIELD.



NOTE: COLOR TO BE BRONZE

LEGEND

- PROPERTY LINE
- NEW SOLID WHITE VINYL FENCE
- NEW DECIDUOUS SHADE TREE
- NEW DECIDUOUS SMALL TREE
- NEW SHRUB
- NEW LIGHT POLE
- NEW LAWN (SOD)
- NEW OPEN SPACE AREA

**PLAN**

SCALE: 1" = 10'

**SITE LIGHTING NOTES:**


- SITE LIGHTING INFORMATION AND LIGHTING PLANS PREPARED BY ENVIRONMENTAL LAND SOLUTIONS, LLC ARE DESIGNED FOR GENERAL LANDSCAPE AESTHETIC PURPOSES ONLY. LIGHTING INFORMATION SHOWN ON THIS PLAN SHALL NOT BE USED FOR SECURITY OR SAFETY PURPOSES.
- LOCATION AND TYPE OF LIGHT FIXTURES ARE TYPICAL AND MAY VARY BASED ON ACTUAL FIELD CONDITIONS. SITE AND ARCHITECTURAL PLAN REVISIONS, USE OF EXISTING LIGHTING (IF ANY), NEW BUILDING MOUNTED LIGHTING, AESTHETICS, AND CONSULTATIONS WITH LIGHTING CONSULTANT AND/OR MANUFACTURER.
- THIS PLAN ASSUMES THAT THE BUILDING WILL HAVE WALL MOUNTED FIXTURES (BY OTHERS) TO LIGHT THE FACADE AND ADJACENT LANDSCAPE AREAS (INCLUDING WALKS AND DOORS).
- PLANTING METHODS SHALL BE IN ACCORDANCE WITH THE "AMERICAN STANDARDS FOR NURSERY STOCK", LATEST EDITION, AS PUBLISHED BY THE AMERICAN NURSERY & LANDSCAPE ASSOCIATION.
- LANDSCAPE IRRIGATION SYSTEMS, SUCH AS HUMIDITY SENSORS OR DRIP IRRIGATION, SHALL BE WATERWISE RATED.

**NOTES:**

- EXISTING AND PROPOSED SITE INFORMATION TAKEN FROM A DIGITAL AUTOCADED SITE PLAN SUPPLIED BY REDUNIS & MEAD.
- EXACT LOCATION OF PROPOSED PLANTINGS AND SPECIES TYPES MAY VARY FROM THIS PLAN BASED ON SITE PLAN REVISIONS AND/OR ACTUAL FIELD CONDITIONS.
- PLANT SPECIES SUBSTITUTIONS MAY BE MADE WITH THE APPROVAL OF THE PROJECT LANDSCAPE ARCHITECT PRIOR TO PLANTING. SUBSTITUTED PLANTS SHALL BE AT AN EQUAL OR GREATER SIZE AS NOTED USING A SIMILAR TYPE PLANT.
- PLANTING METHODS SHALL BE IN ACCORDANCE WITH THE "AMERICAN STANDARDS FOR NURSERY STOCK", LATEST EDITION, AS PUBLISHED BY THE AMERICAN NURSERY & LANDSCAPE ASSOCIATION.
- LANDSCAPE IRRIGATION SYSTEMS, SUCH AS HUMIDITY SENSORS OR DRIP IRRIGATION, SHALL BE WATERWISE RATED.

**PLANT LIST**

QTY	KEY	BOTANICAL NAME	COMMON NAME	SIZE	ROOT	STREET TREE	TREE SIZE	REMARKS	PLANTING HT.	MATURE HT.
4	AR	ACER RUBRUM 'ARMSTRONG'	RED BARK MAPLE	2-1/2" CAL	B&B	4	MEDIUM	COLUMNAR	13-14 HT.	45-50 HT.
4	BH	BETULA NIGRA 'HERITAGE'	HERITAGE BIRCH	8-10" HT.	B&B	0	MEDIUM	COLUMLAR	8-10 HT.	40-50 HT.
1	CO	CELTIS OCCIDENTALS	HACKBERRY	2-2 1/2" CAL	B&B	1	MEDIUM	NATIVE ROUND	13-14 HT.	50-60 HT.
1	WV	CELTIS OCCIDENTALS	HACKBERRY	2-2 1/2" CAL	B&B	0	MEDIUM	NATIVE ROUND	13-13 HT.	35-40 HT.
5	AC	AMELANCHIER CANADENSIS	SHADBLOW	5-6" HT.	B&B	3	SMALL	NATIVE WHITE FLOWERS	5-6 HT.	18-22 HT.
3	SF	AMELANCHIER 'SPRING FLURY'	SPRING FLURY SHAD	2-2 1/2" CAL	B&B	0	SMALL	SINGLE STEMMED TREE, NATIVE	8-9 HT.	20-25 HT.
43	TO	THUJA OCCIDENTALIS 'EMERALD GREEN'	EMERALD GREEN ARBORVITAE	6-7" HT.	B&B	0	MEDIUM	EVERGREEN TREE, COLUMNAR	6-7 HT.	18-22 HT.
31	BO	HYDRANGEA 'BOBO'	BOBO HYDRANGEA	2-3" HT.	CONT.	N/A	N/A	WHITE FLOWERS	2" HT.	3" HT.
20	SI	HYDRANGEA 'SUNBURST'	SUNBURST ST. JOHNSWORT	18-24" HT.	CONT.	N/A	N/A	NATIVE YELLOW FLOWER	2" HT.	3" HT.
24	IS	ILEX GLABRA 'STEEDES'	STEEDES HOLLY	3-4" HT.	CONT.	N/A	N/A	EVERGREEN	3-4" HT.	6-7" HT.
32	IG	ILEX GLABRA 'SHAWNOCK'	SHAWNOCK HICKBERRY	2-3" HT.	CONT.	N/A	N/A	EVERGREEN, NATIVE	2" HT.	3" HT.
23	JA	JUNIPERUS CHINENSIS VAR. 'BLUE PACIFIC'	BLUE PACIFIC JUNIPER	18-24" HT.	CONT.	N/A	N/A	EVERGREEN	12" HT.	12" HT.
12	LA	LEUCODIEN DRONCEN VAR. 'SARAH'S CHOICE'	SARAH'S CHOICE LEUCODIEN	2-3" HT.	CONT.	N/A	N/A	EVERGREEN	2-3 HT.	4 HT.
3	RC	RHOODODENDRON 'ALBUM ELEGANS'	ALBUM ELEGANS RHOODODENDRON	3-4" HT.	B&B	0	SMALL	SPREADING, WHITE	3-4 HT.	6-8" HT.
16	WR	ROSA 'WHITE MEDIAN'	WHITE MEDIAN ROSE	2-3" SPR.	CONT.	N/A	N/A	SPREADING, WHITE	2" HT.	3" HT.
31	S8	SPRUEA SHIROBANA'	SHIROBANA SPREA	42-48" HT.	B&B	N/A	N/A	WHITE AND PINK FLOWERS	18" HT.	3" HT.
1	MK	SYRINGA 'MISS KIVI'	MISS KIVI LILAC	2-3" HT.	CONT.	N/A	N/A	LIGHT PURPLE, FRAGRANT	3-4" HT.	7-8" HT.
11	VM	VIBURNUM PENTATHAM	ARROWWOOD	3-4" HT.	CONT.	N/A	N/A	NATIVE WHITE FLOWERS	3" HT.	6" HT.
6	VD	VIBURNUM BURKWOODII 'MOHAWK'	MOHAWK VIBURNUM	3-4" HT.	B&B	N/A	N/A	FRAGRANT, SEMI-EVERGREEN	3-4" HT.	7-8" HT.

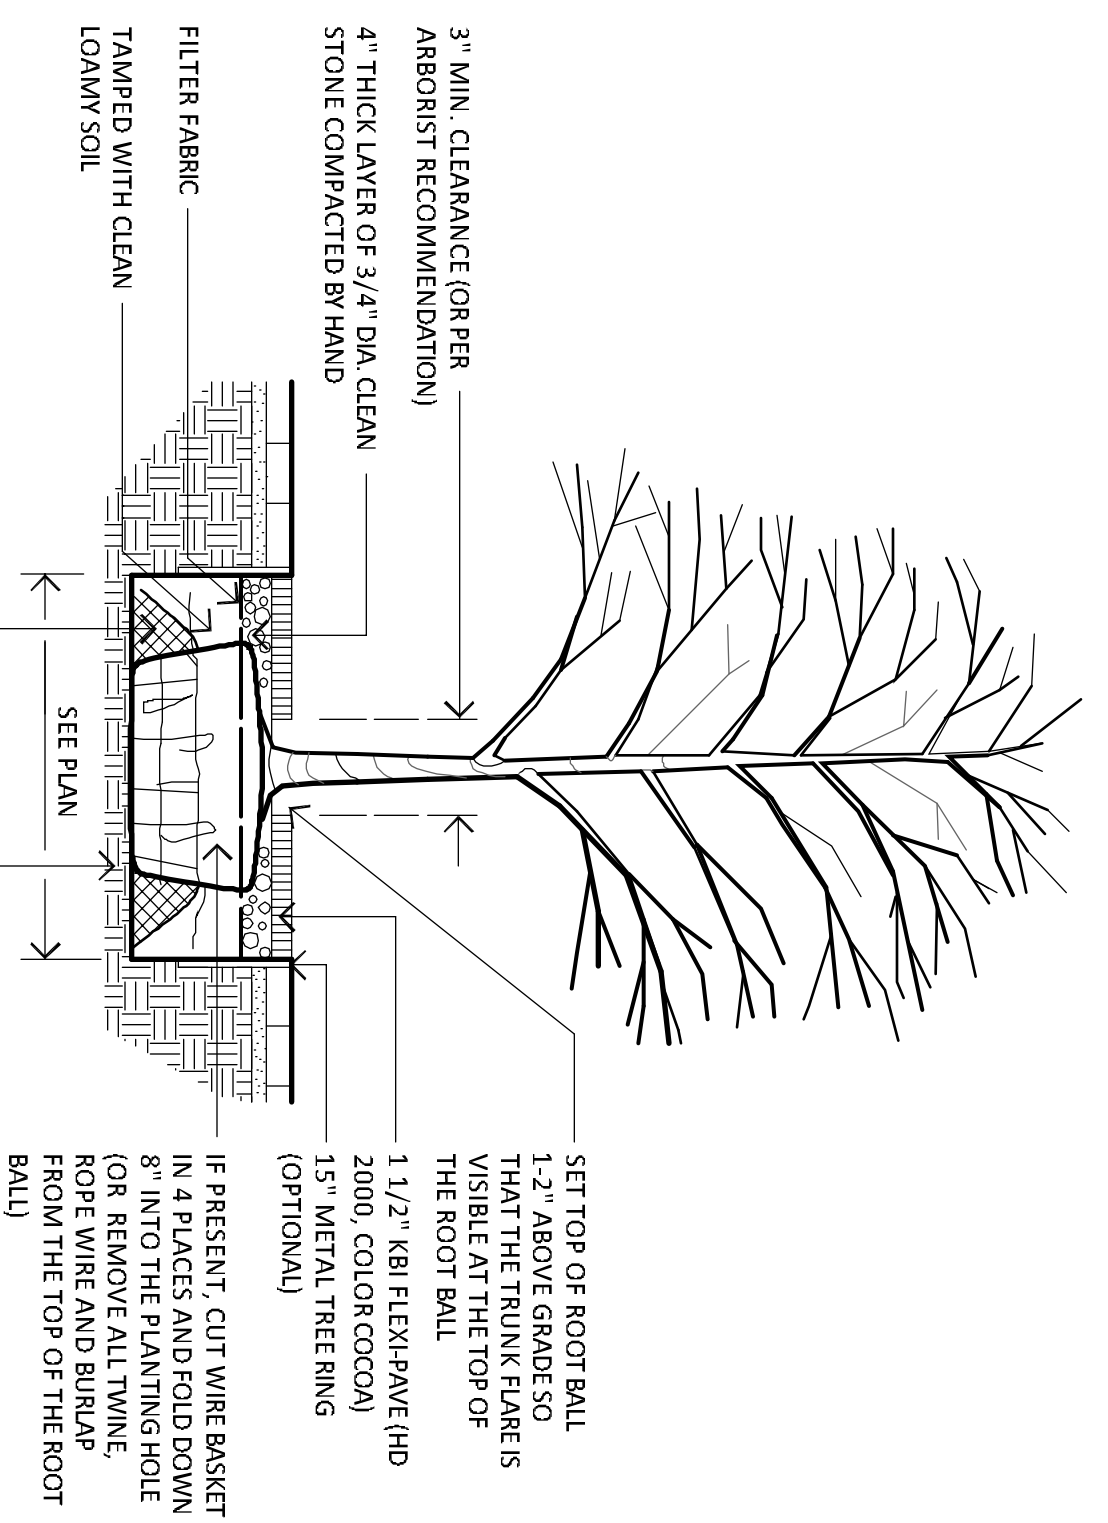

3" MIN. CLEARANCE (OVER PER ANCHOR) (RECOMMENDATION)  
4" THICK LAYER OF 3/4" DIA. CLEAN STONE COMPACTED BY HAND


1 1/2" KBI FLEXI-PAVE  
2000, COLOR COCOA (OPTIONAL)

IF PRESENT, CUT WIRE BASKET IN 4 PLACES AND FOLD DOWN 8" INTO THE PLANTING HOLE (OR REMOVE ALL TWINE FROM THE TOP OF THE ROOT BALL)

PLACE ROOT BALL ON UREXCAVATED OR COMPACTED SOIL UNDER BALL TO PREVENT SETTLEMENT

**KBI FLEXI-PAVE TREE PLANTING DETAIL**

SCALE: NOT TO SCALE

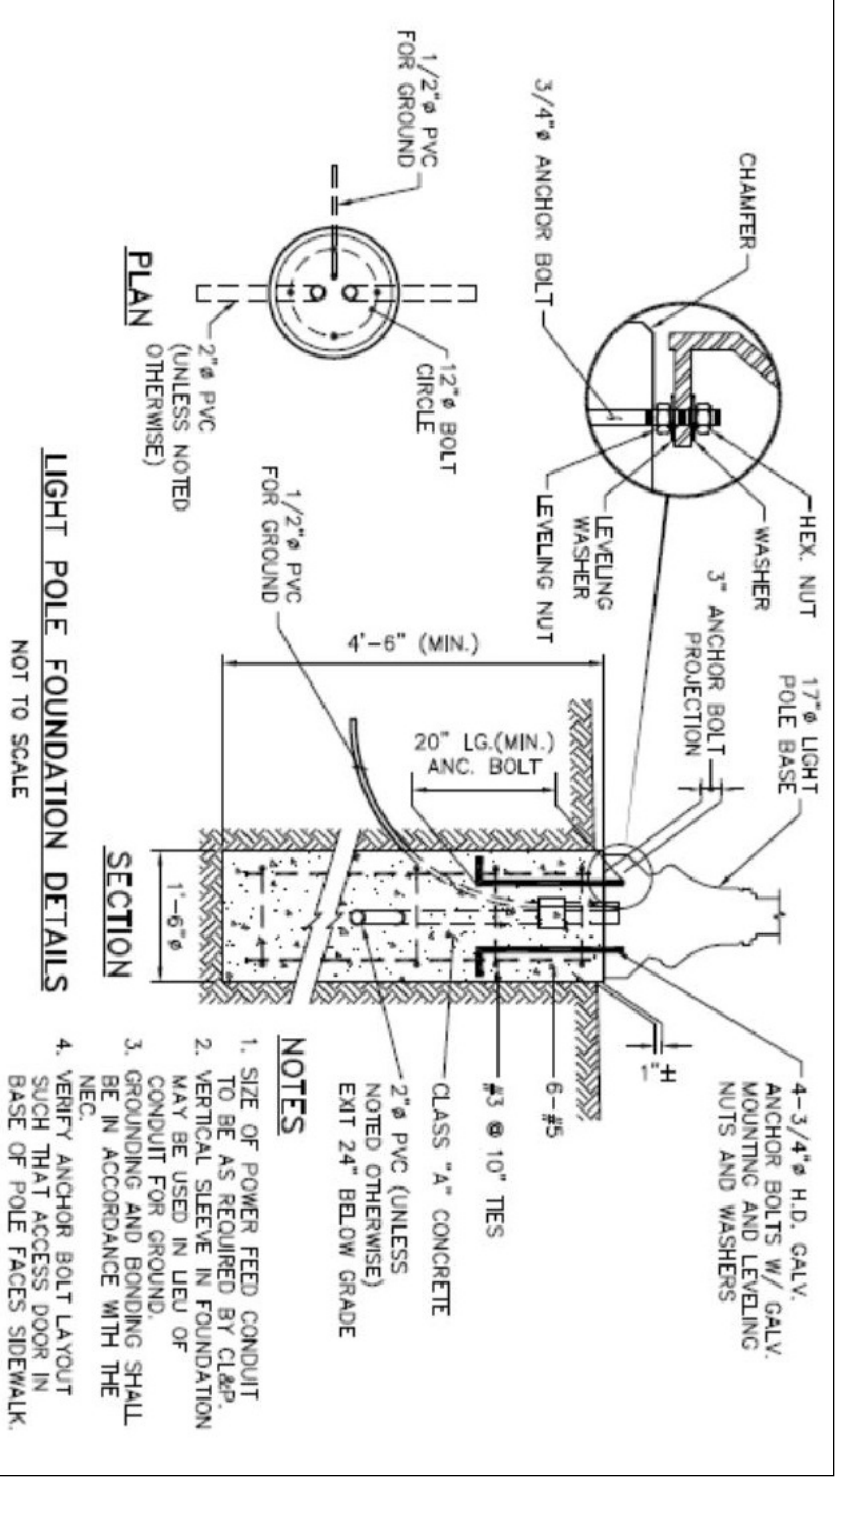

**LIGHT POLE FOUNDATION DETAILS**

NOTE: INSTALL LIGHT POLE PER THE MANUFACTURERS RECOMMENDATIONS.

**CITY OF STAMFORD LIGHT POLE FOOTING DETAIL**

SCALE: NOT TO SCALE

PERMITS: CALL BEFORE YOU DIG

ENVIRONMENTAL LAND SOLUTIONS, LLC  
Landscape Architecture and Environmental Planning  
8 KNIGHT STREET SUITE 203  
NORWALK, CONNECTICUT 06851  
Tel: (203) 855-7879 Fax: (203) 855-7836  
Info@elsllc.net www.elsllc.net

ENVIRONMENTAL LAND SOLUTIONS, LLC  
ARCHITECTURE & PLANNING

PROJECT: 488 GLENBROOK ROAD STAMFORD, CONNECTICUT  
DATE: 7.1.25  
SCALE: AS SHOWN  
DRAWING NO: LP.1